

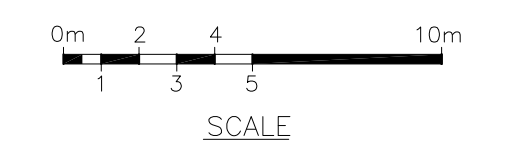




BASEMENT FLOOR PLAN

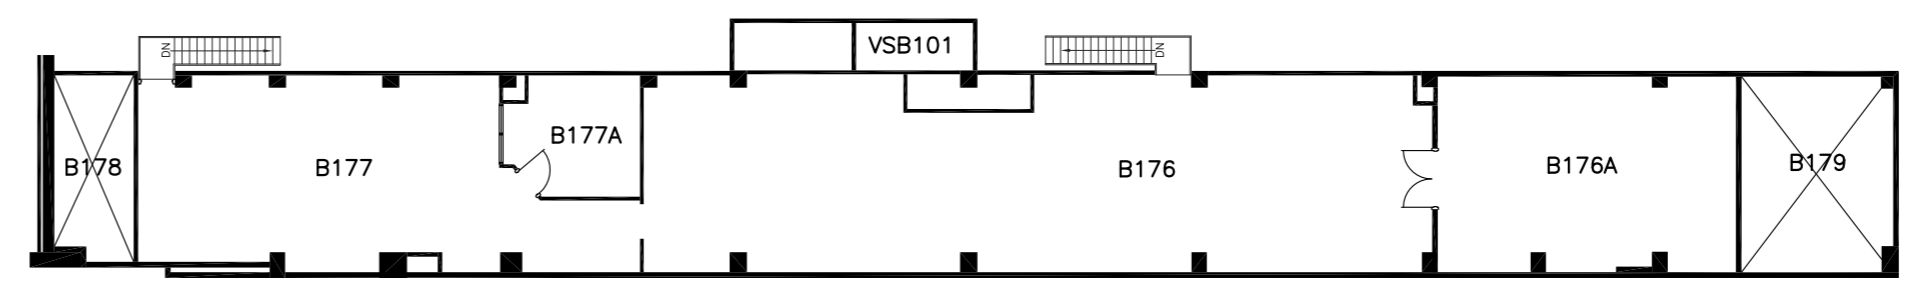


5		DR'N	P.D.	Queen's University Physical Plant Services			
		By:					
4		DATE:	OCT'96	McARTHUR HALL			
3	NOV 2015	WASHROOM A030F	APP'D	BLDG. No.	BLOCK	LEVEL	C.A.D.D. REF.
				BASEMENT	157-00		
2	MAY 2014	UPDATE FOR ARCHIBUS	SCALE:	PROJECT No. / FILE No.	DRAWING No.	REV.	
			AS SHOWN	157	A001	3	
1	AUG 2004	UPDATE FOR VFM	FILE NO.				
			157				
0	DATE	REVISION	DWG. 1 OF 5				

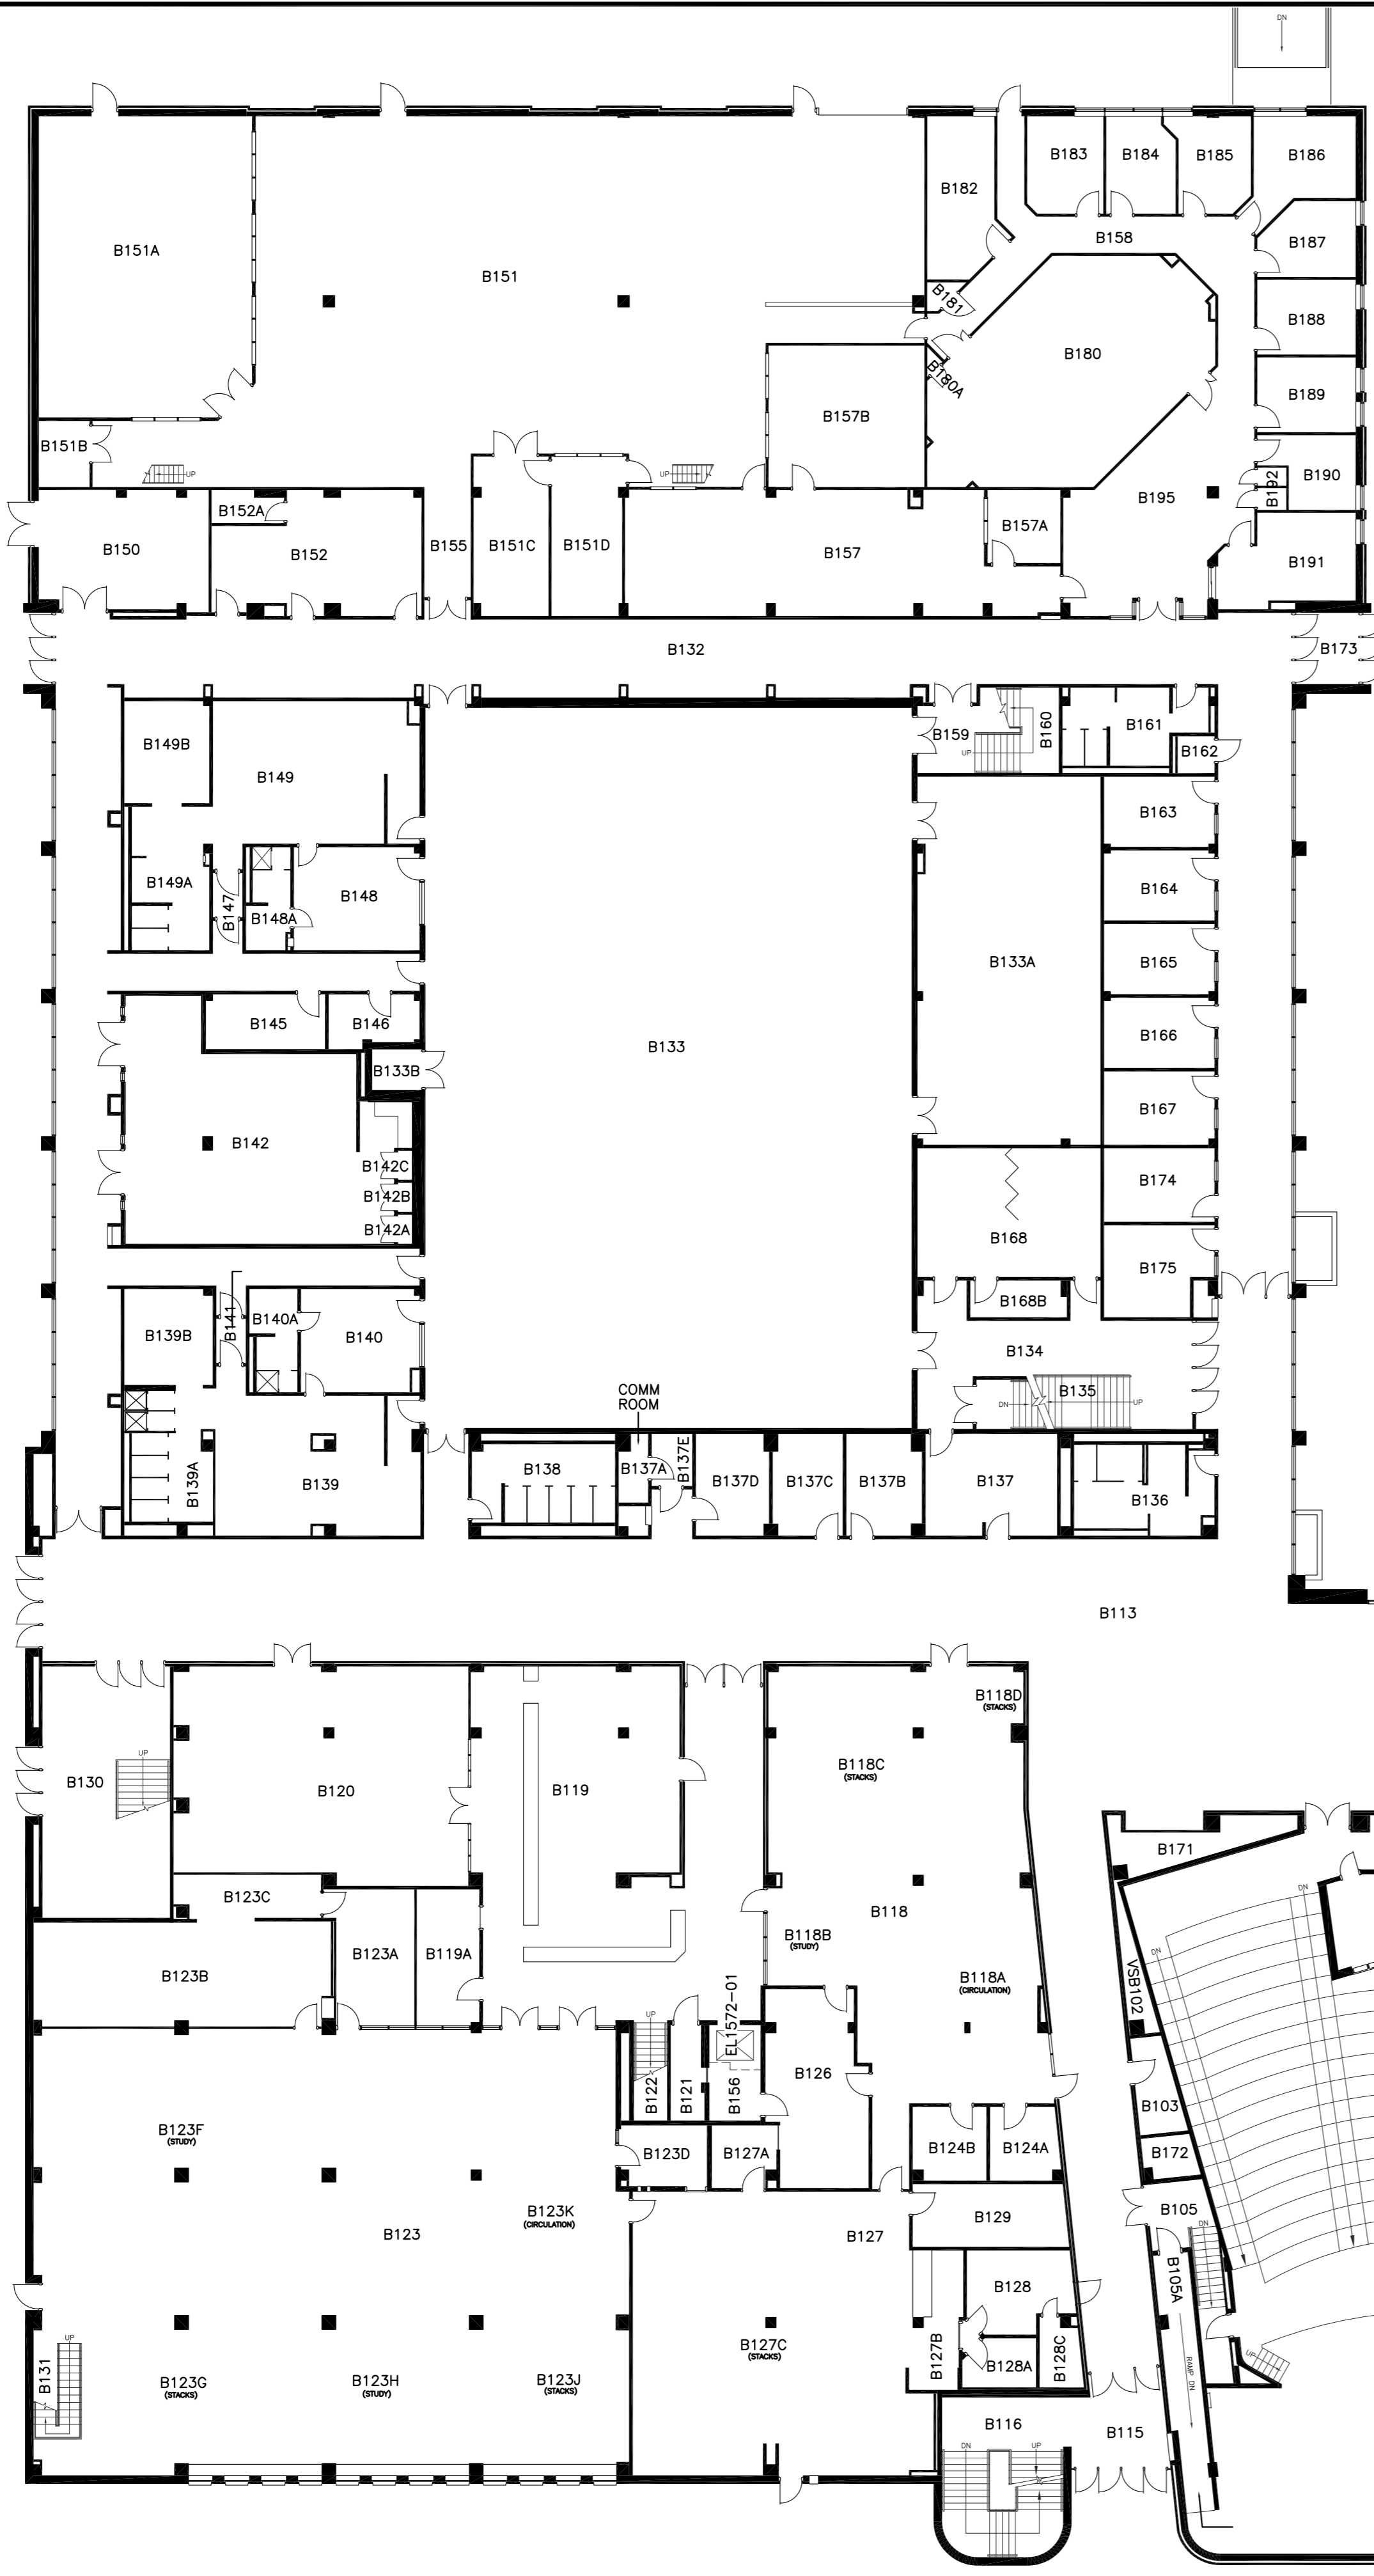


MEZZANINE SECTION
ABOVE B157

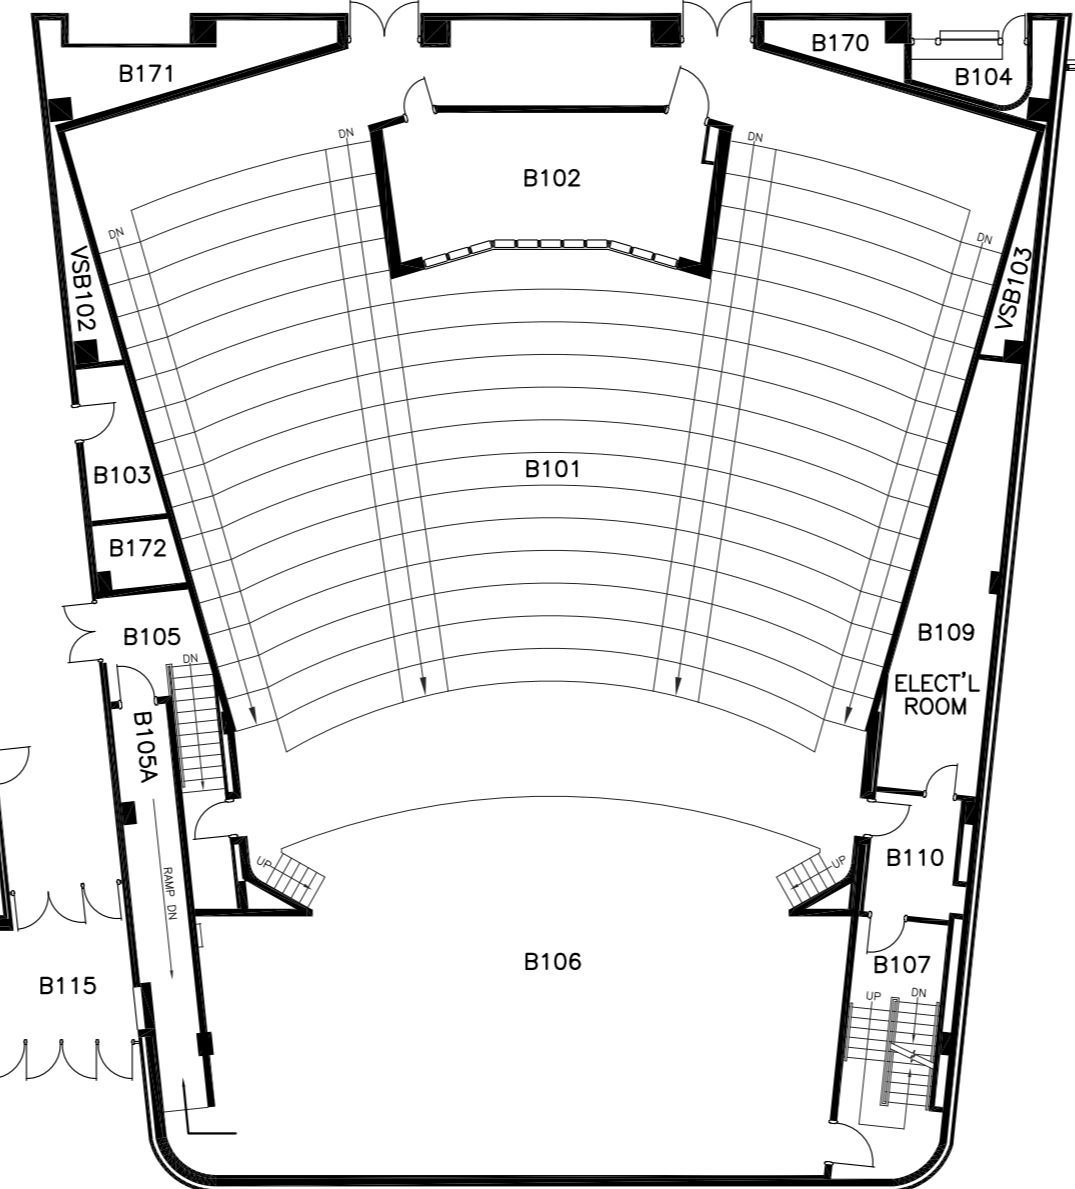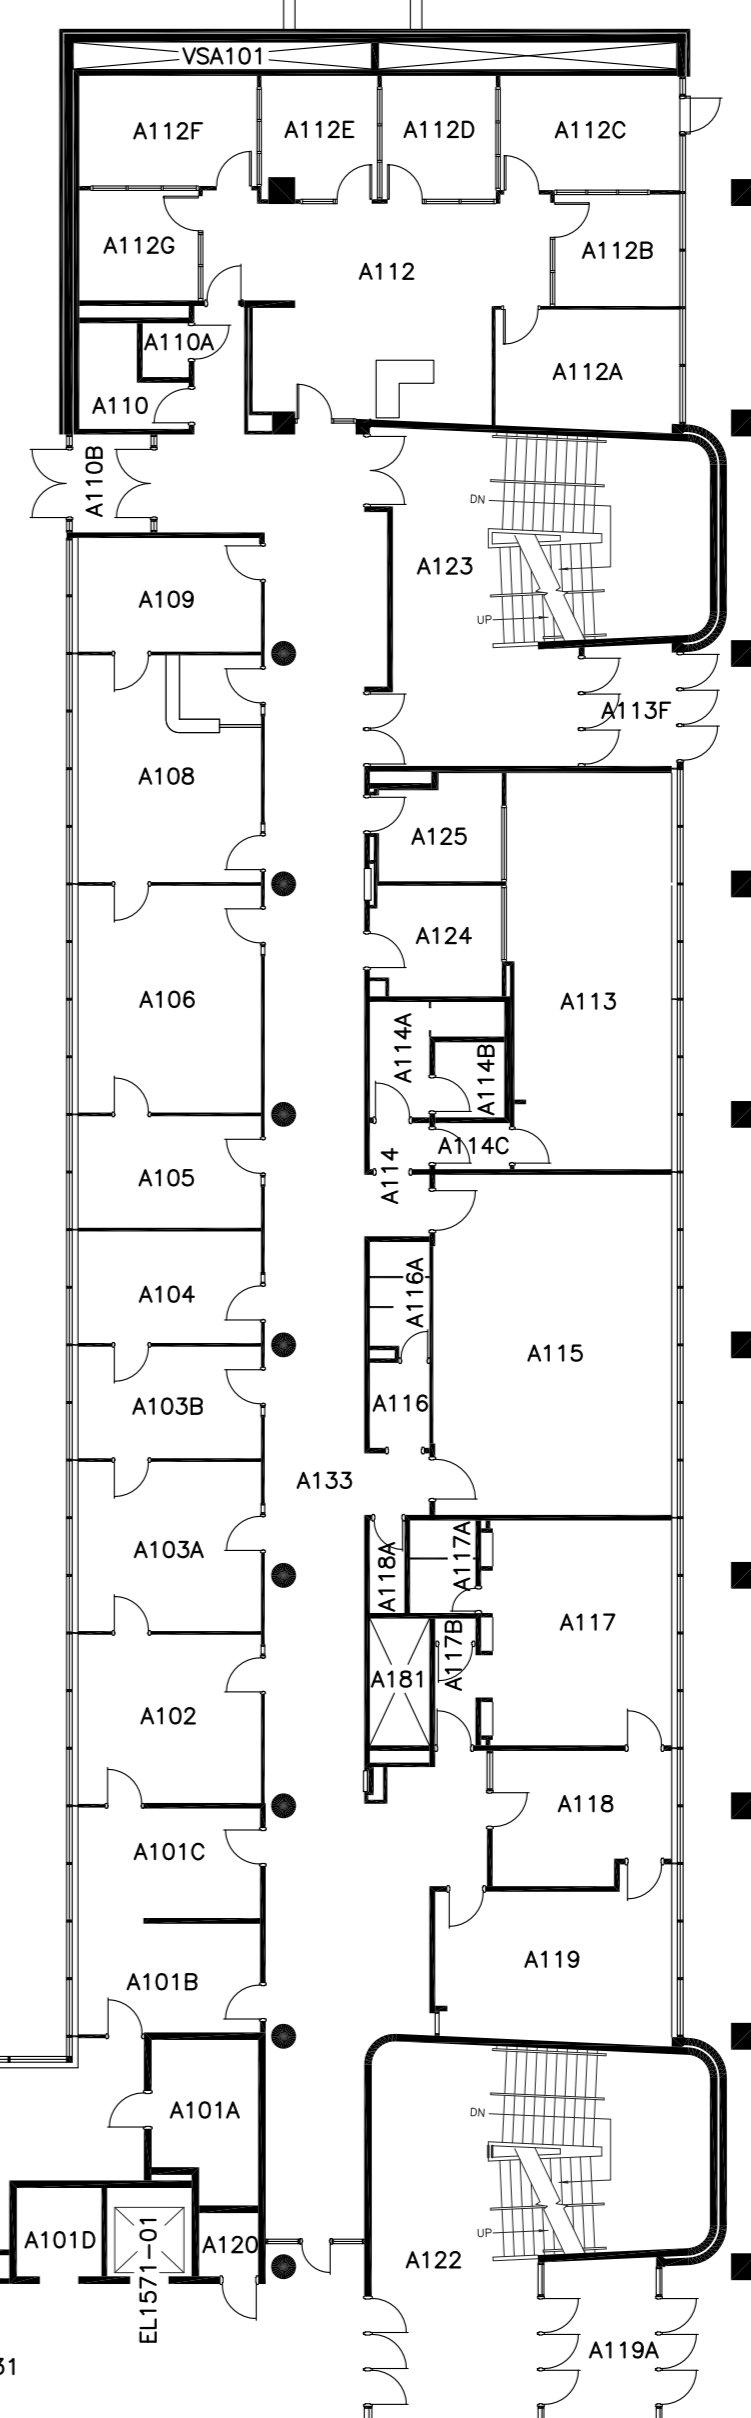



UPPER STAGE AREA

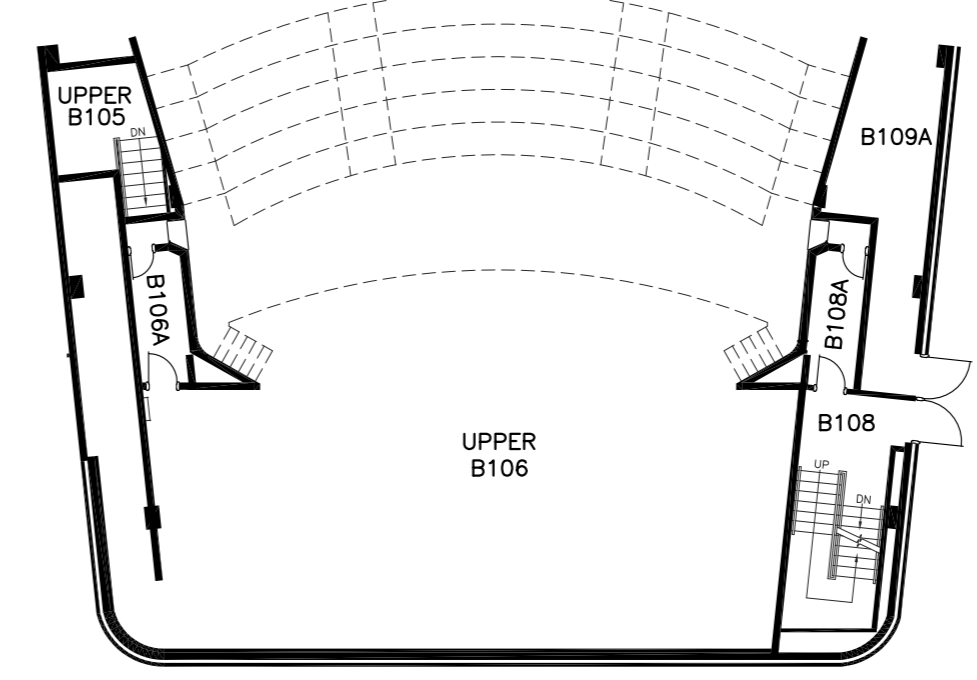



FIRST FLOOR PLAN

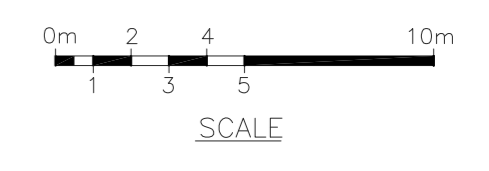


DR'N BY: P.D.	DATE: NOV'96	Queen's University Physical Plant Services			
APP'D BY:	SCALE: AS SHOWN	McARTHUR HALL			
REV 2015 ADD ROOM B157B	FILE NO. 157	BLDG. No. 157	BLOCK 1	LEVEL 1	C.A.D.D. REF. 157-01
REV 2014 LIBRARY CORRECTIONS STACKS/STUDY AREAS DEFINED	DATE	PROJECT No. / FILE No. 157	DRAWING No. A002	REV. 1.3	
DWG. 2 OF 5					

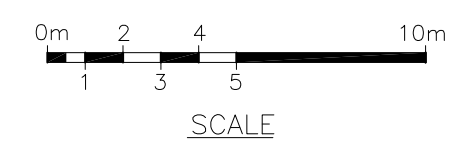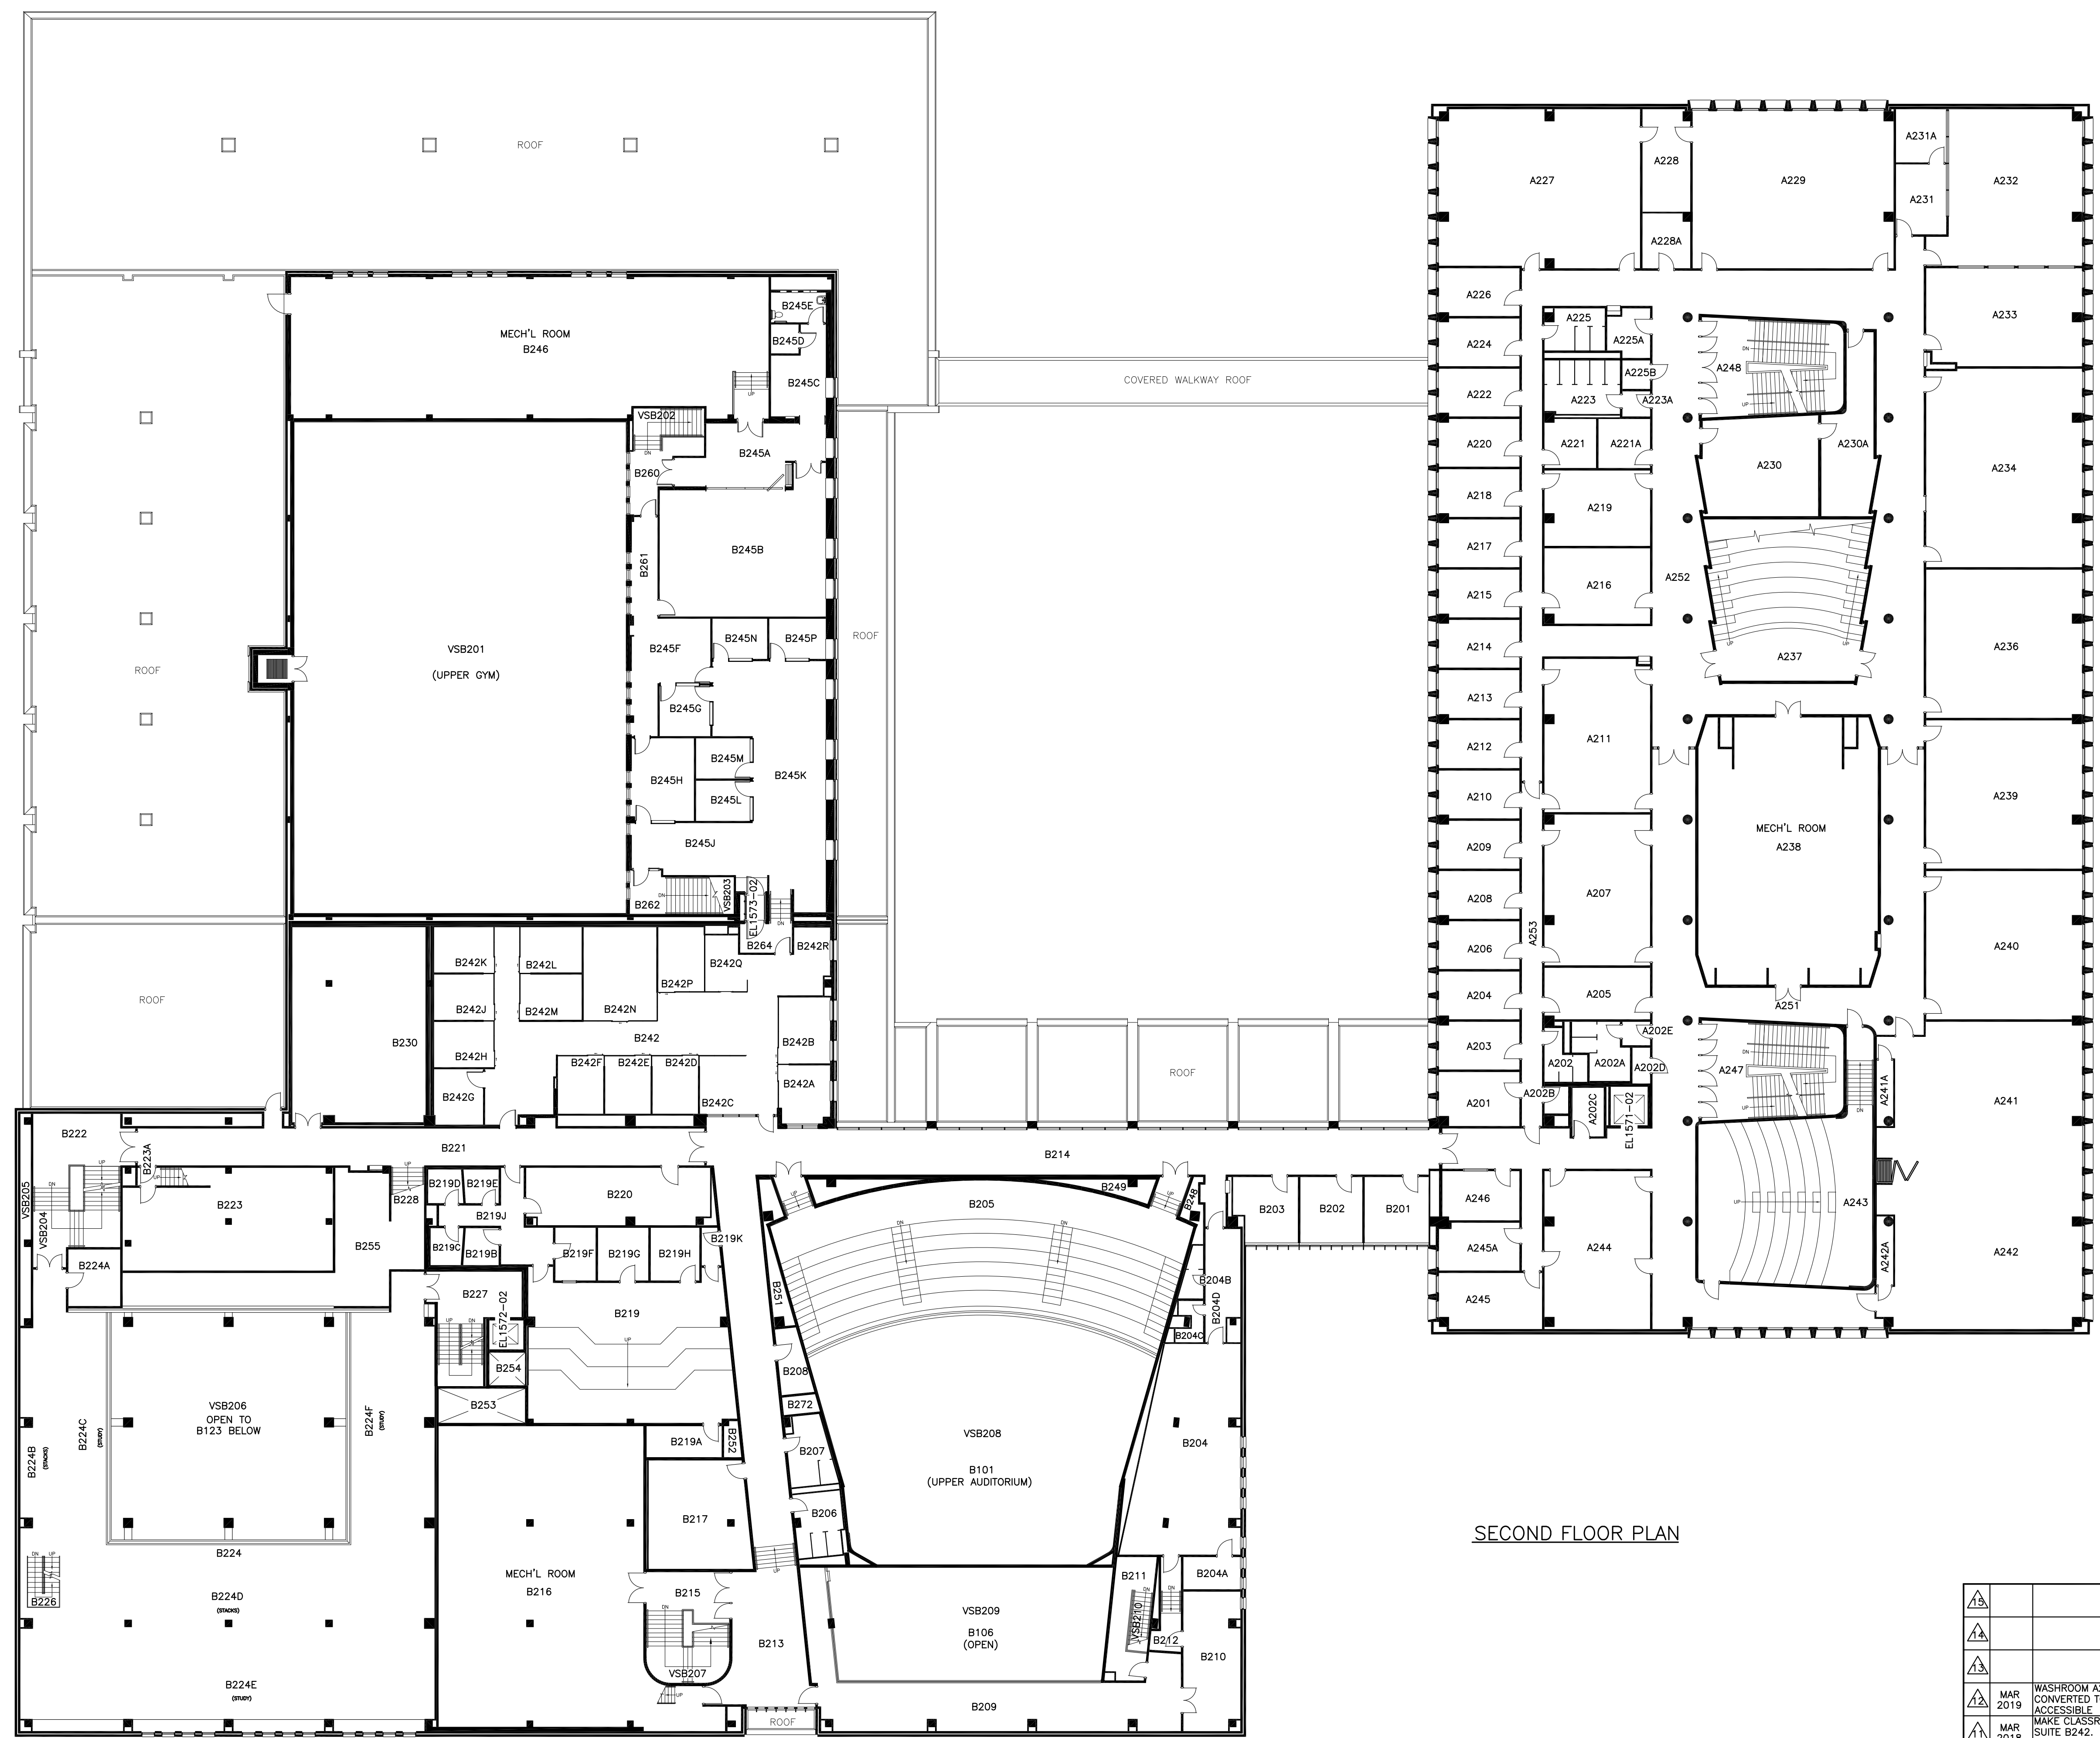


	DR'N	P.D.	Queen's University Physical Plant Services			
	BY:	DEC'96				
	APP'D		McARTHUR HALL			
	BY:					
	SCALE:	AS SHOWN	BLDG. No.	BLOCK	LEVEL	C.A.D.D. REF.
		FILE NO.	157	157	2	157-02
	DATE	REVISION	PROJECT No. / FILE No.	DRAWING No.	REV.	
			157	A003	12	

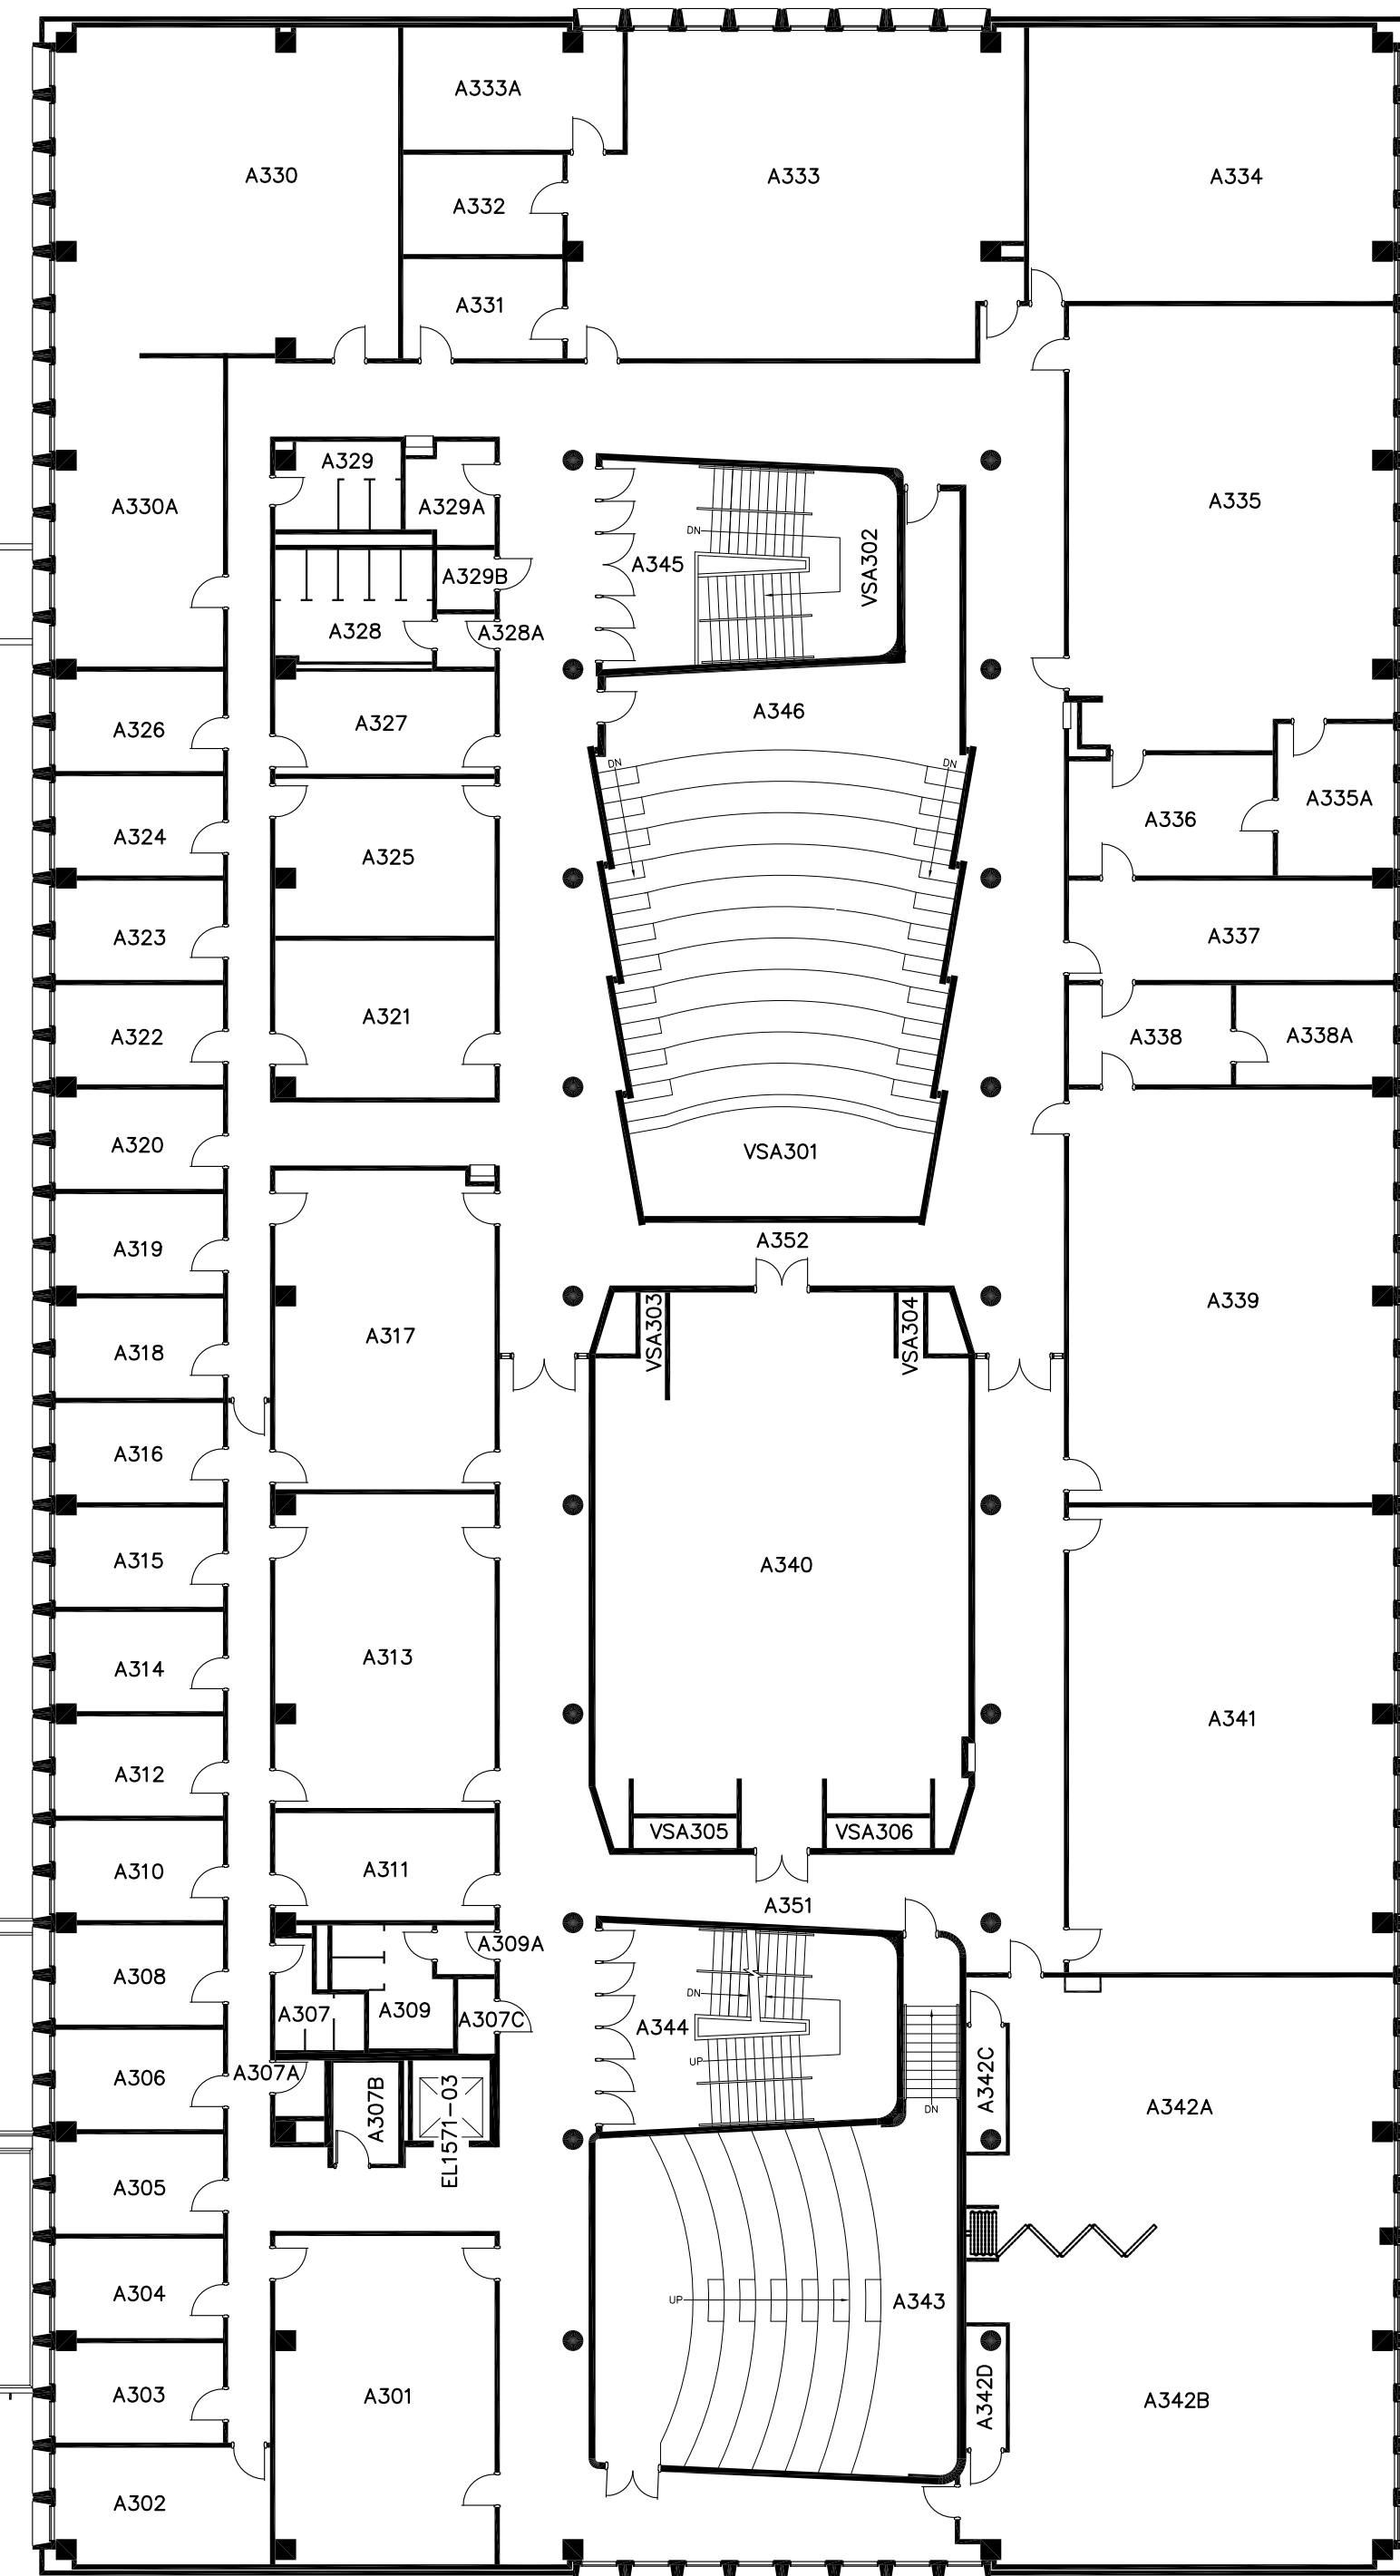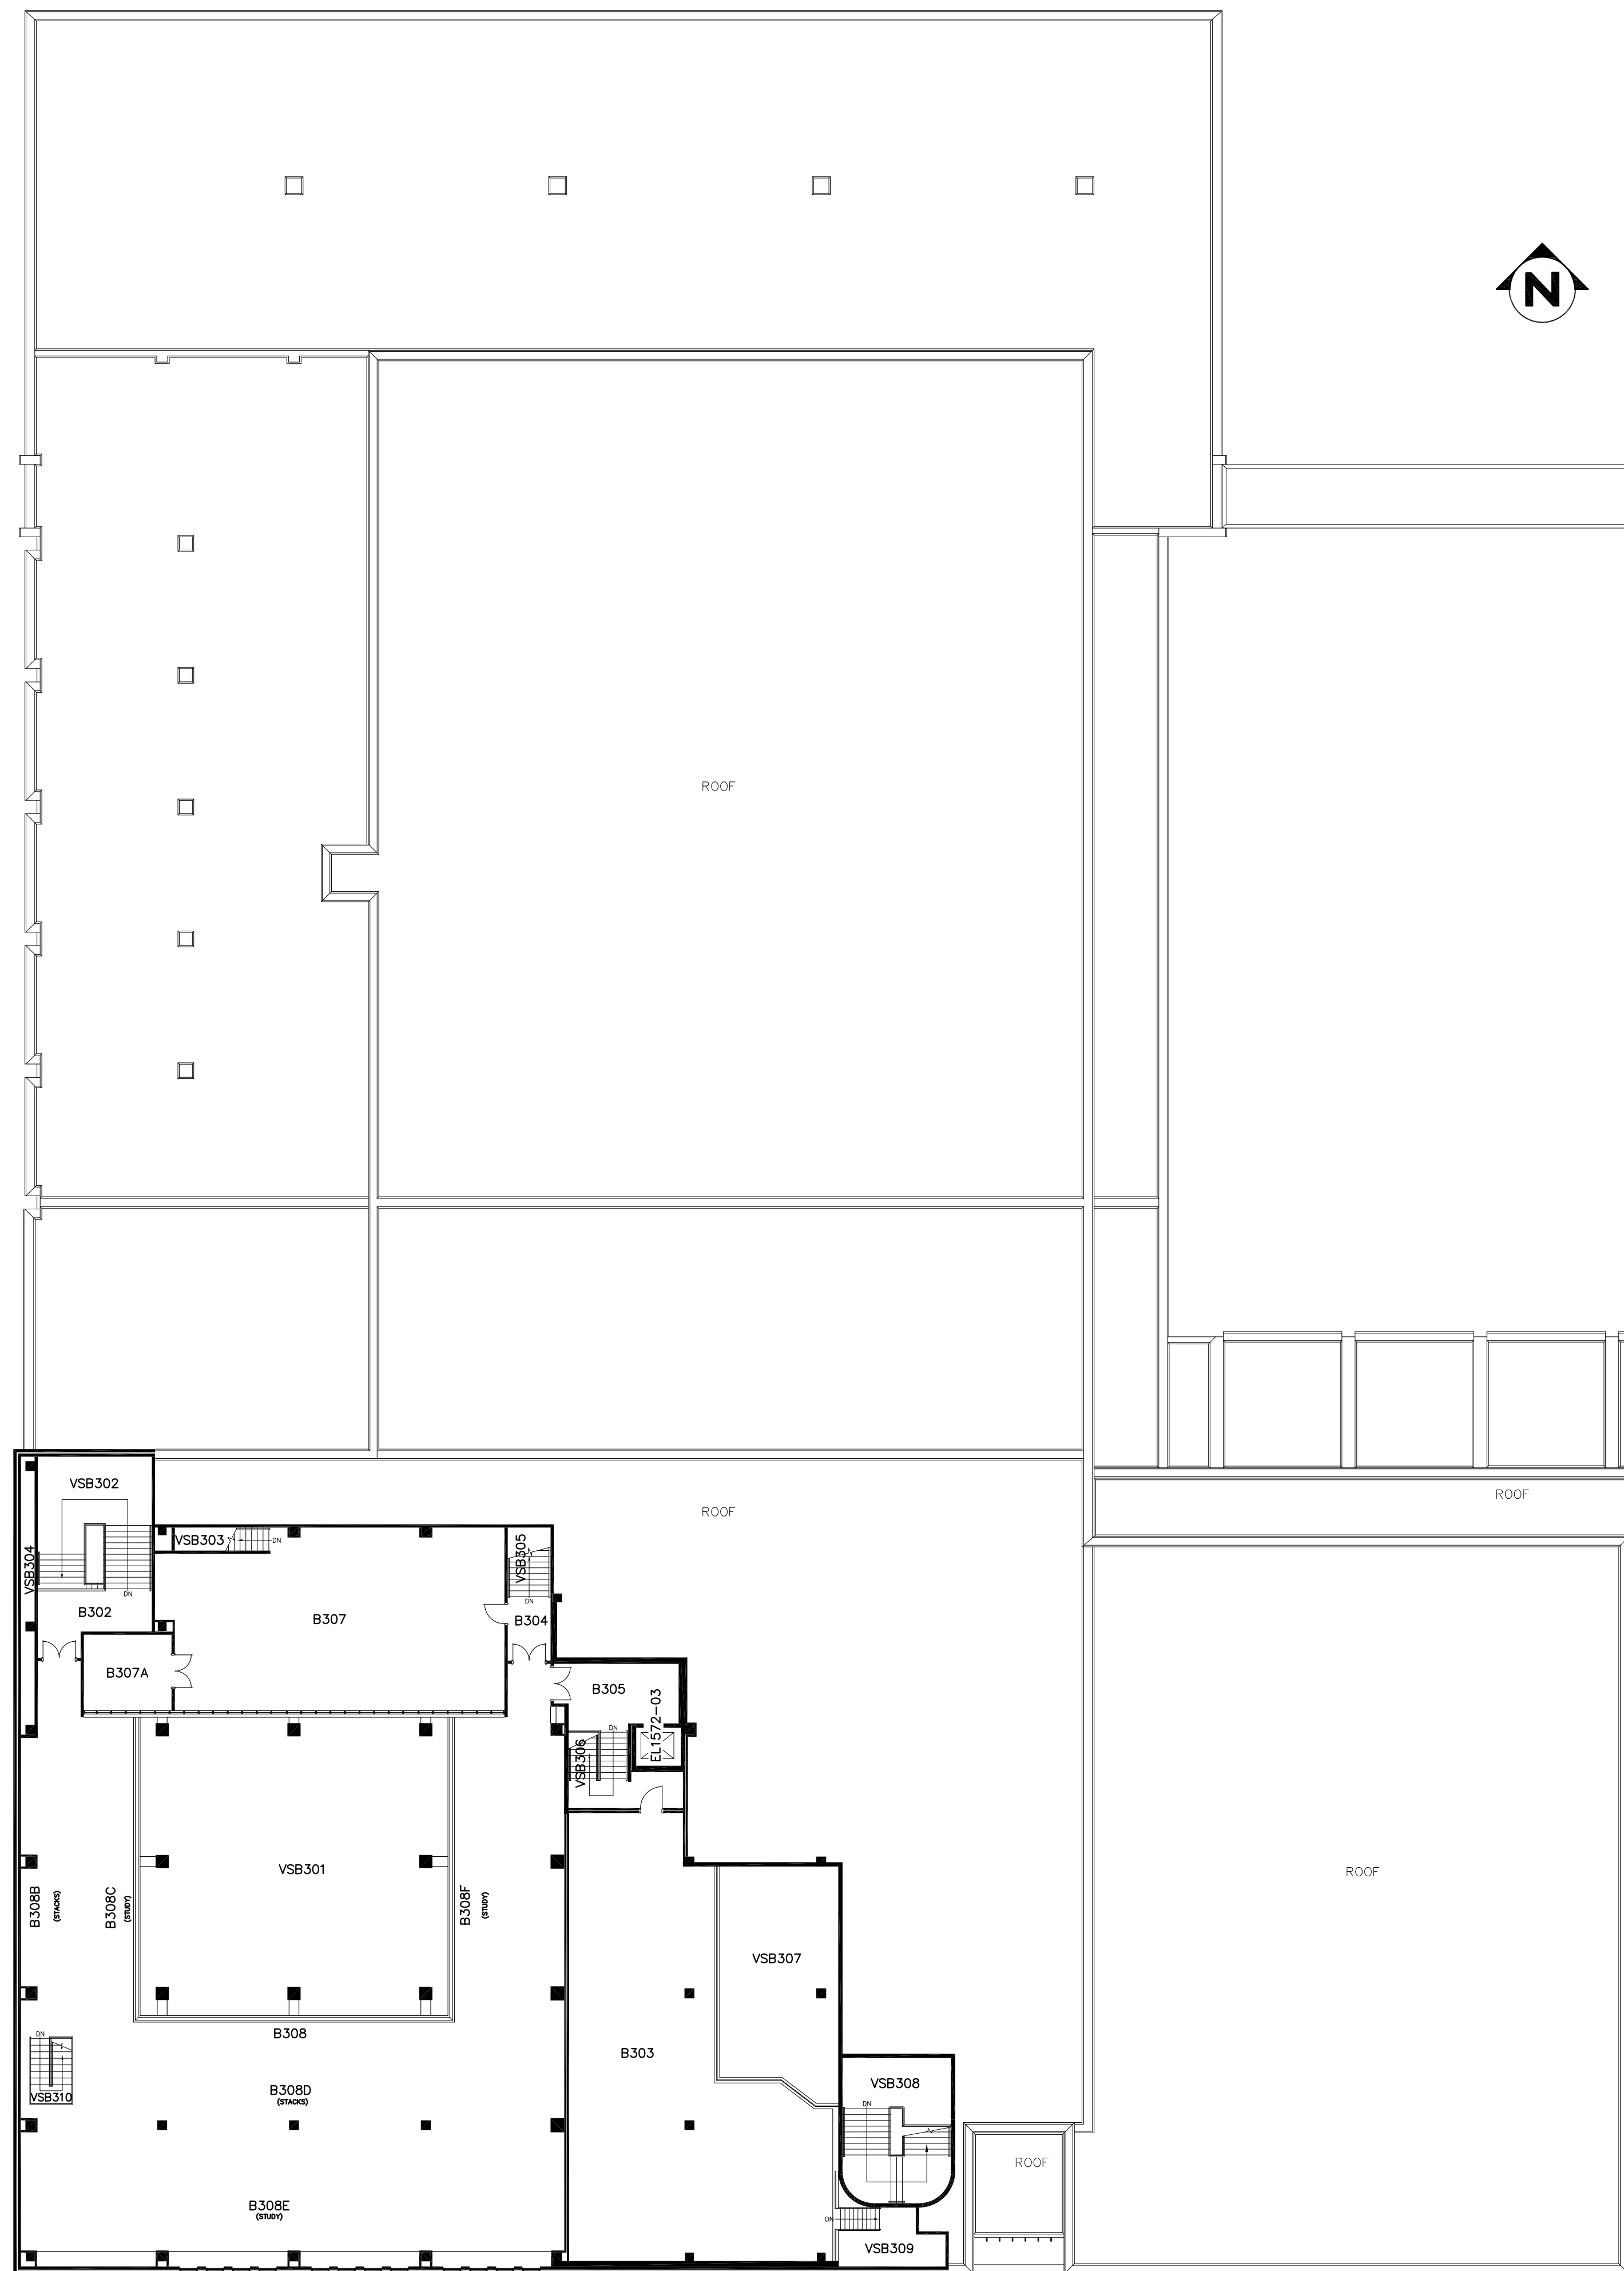


THIRD FLOOR PLAN

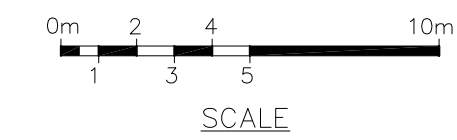

DR'N By: MAR 2019	P.D. DATE: DEC'96	Queen's University Physical Plant Services	
APR 2018	APP'D By: AS PER PROJECT PPS-17-00954		
FEB 2018	SCALE: AS SHOWN	McARTHUR HALL	
NOV 2015	FILE NO. 157		
DATE	REVISION	DWG. 4 OF 5	REV. 9
PROJECT No. / FILE No. 157		DRAWING No. A004	C.A.D.D. REF. 157-03

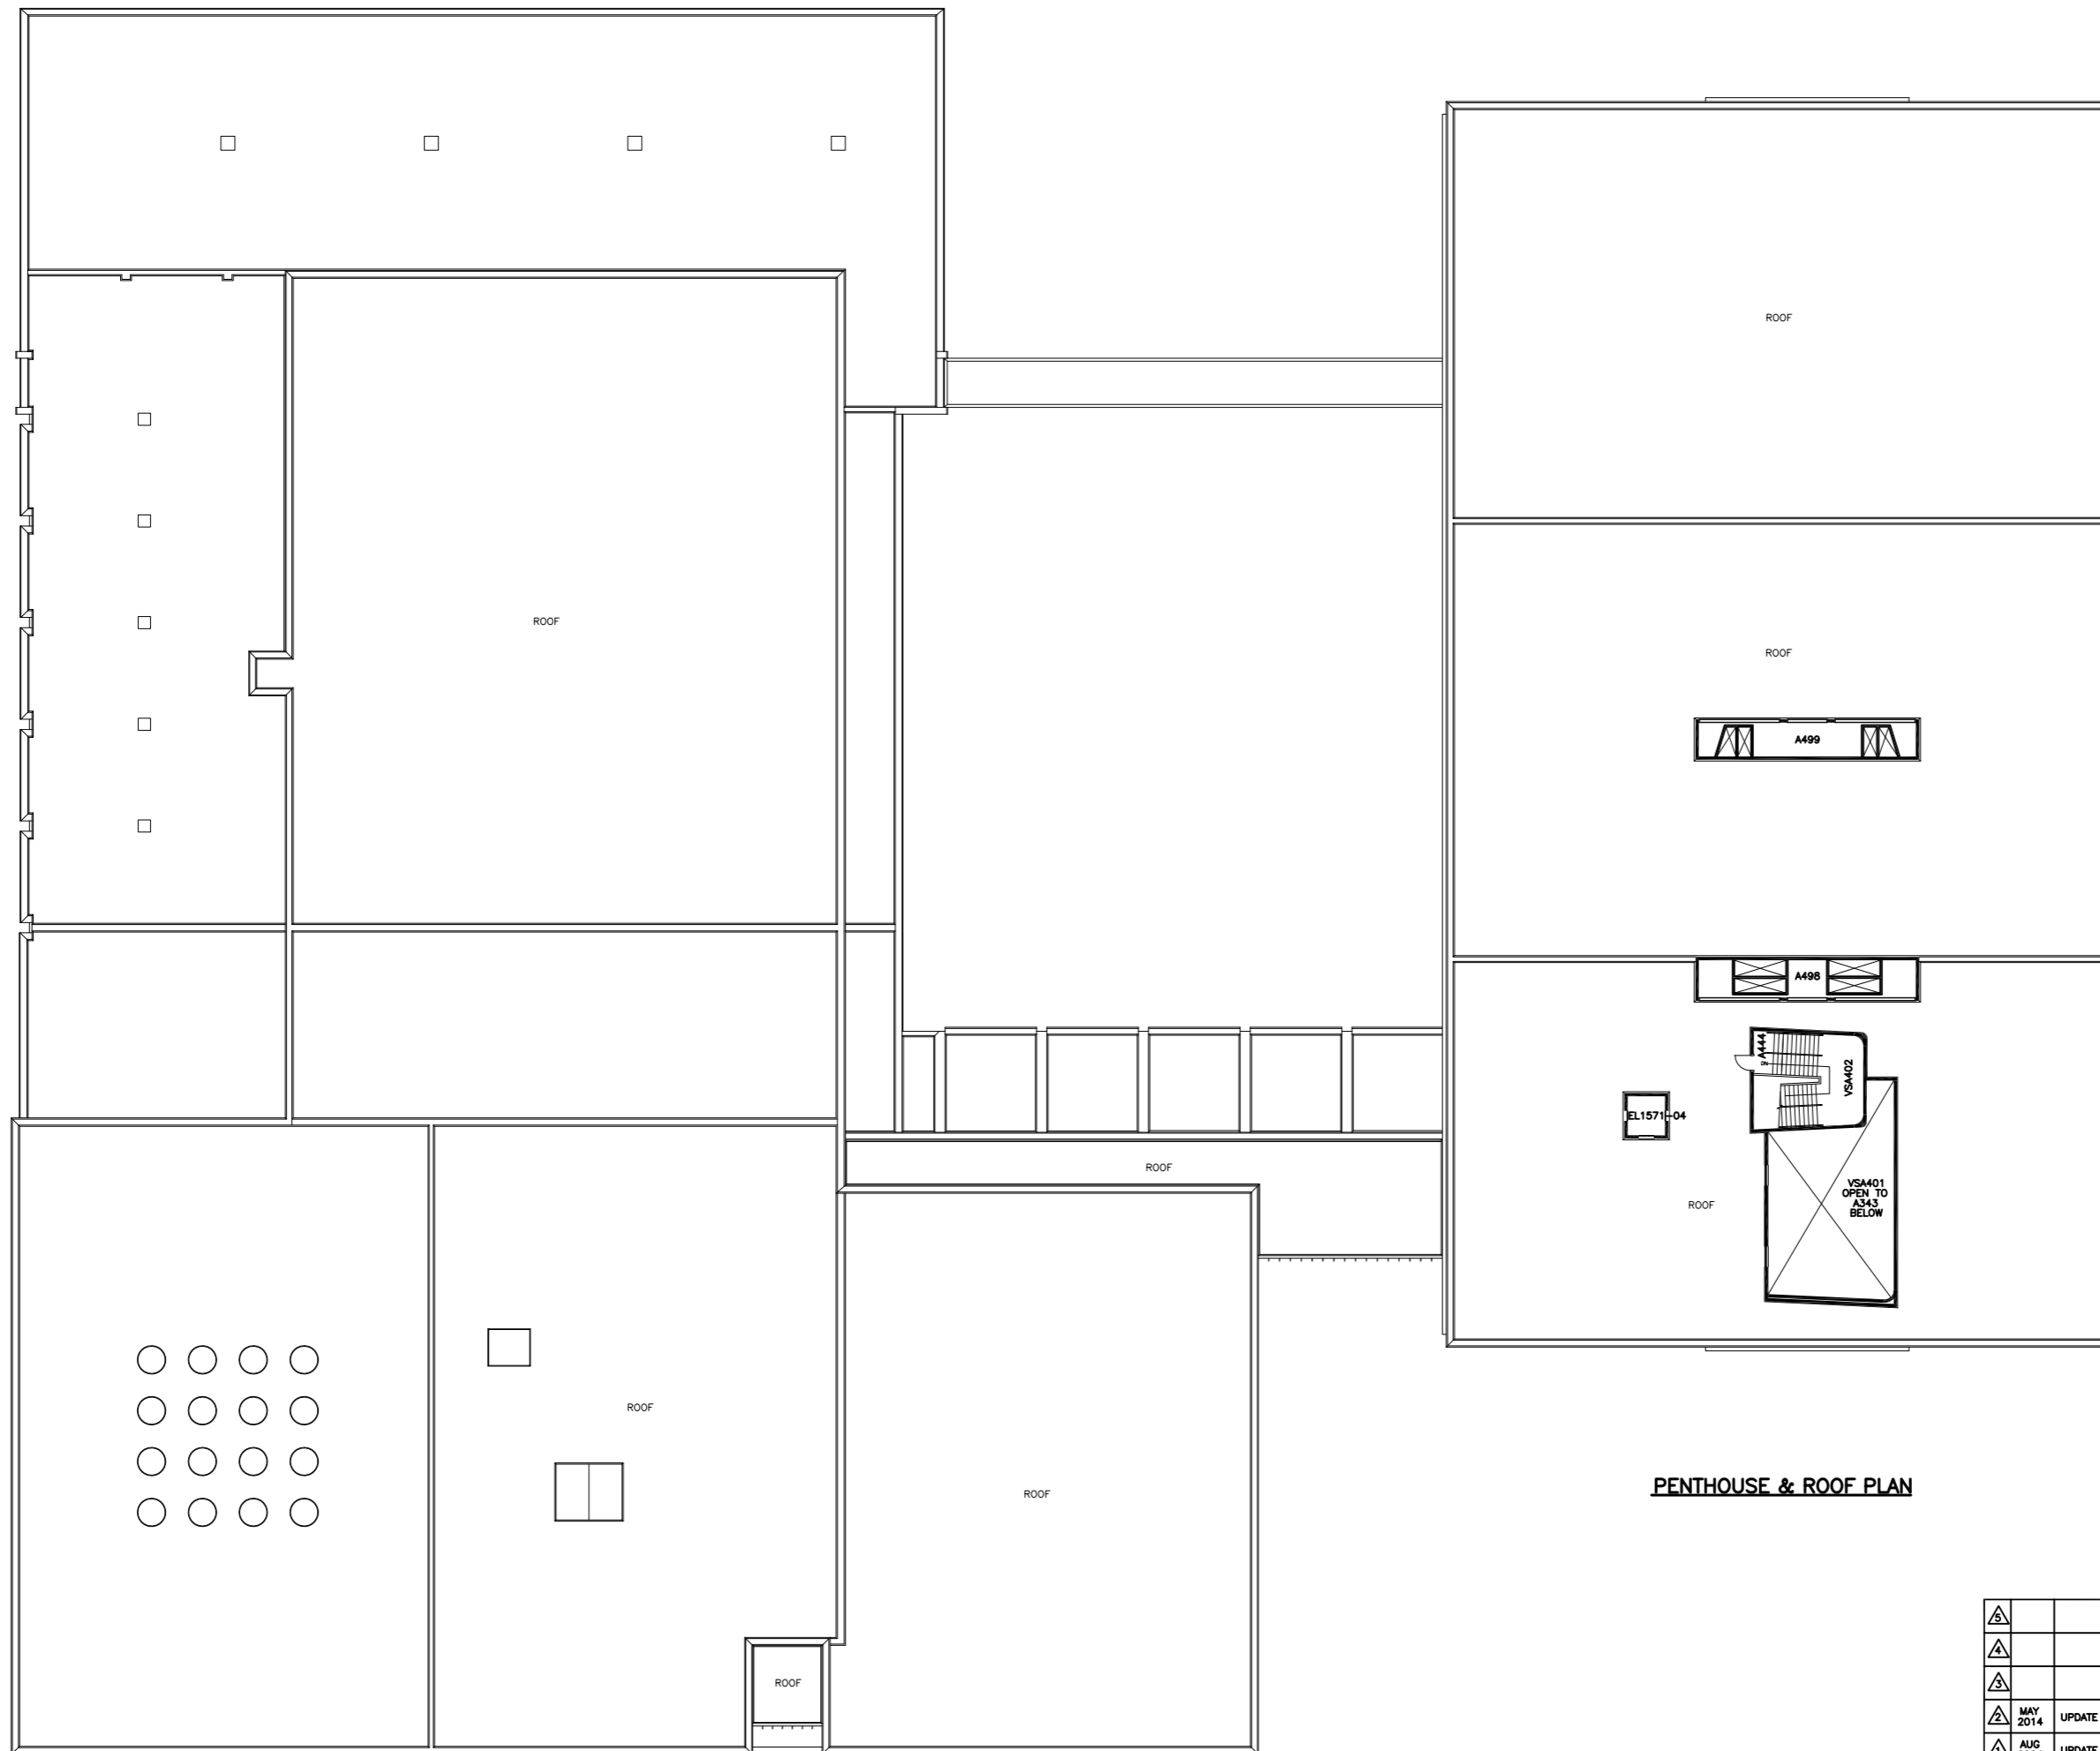

PENTHOUSE & ROOF PLAN

 

		DR'N BY: P.D.	Queen's University Physical Plant Services			
		DATE: JAN'97				
		APP'D BY:	McARTHUR HALL			
		SCALE: AS SHOWN				
MAY 2014	UPDATE FOR ARCHIBUS	FILE NO. 157	BLDG. No. 157	BLOCK	LEVEL ROOF	C.A.D.D. REF. 157-04
AUG 2004	UPDATE FOR VFM	DWG. 5 OF 5	PROJECT No. / FILE No. 157	DRAWING No. A005	REV. 2	
DATE	REVISION					